





Light		
	Selecon Pacific 9°-19°	10
	Selecon Pacific 12-28°	6
	Selecon Pacific 23/50°	34
	5kW Fresnel	1
	PAR 64 MFL	16
	PAR 64 VN5P	36
	ETC Source 4 PAR (VN5P)	4
	4-Bar ACL	12
	Beamlight 1k	1
	Strand Orion 1k	21
	Strand Iris 4 Square Cyc Light	7
	Sodium Flood (Company)	2
	LED Birdie (Company)	1
Moving Light		
	Clay Paky Alpha Profile 1500	4
Accessory		
	6" Top Hat	4
Typical		
	Color Channel	

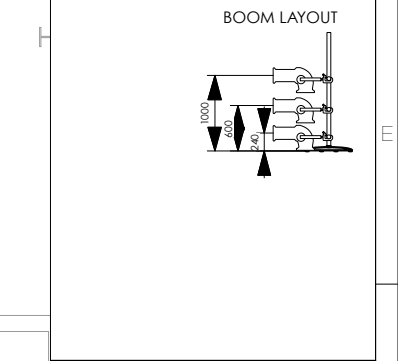

information

client	Akram Khan Company
project	ITMOI
venue	ASB Theatre
title Lighting Plan	
designer	scale 1:100
drawn RF/PL	date 2015-02-25

AUCKLAND ARTS FESTIVAL
 Auckland Arts Festival
 Lvl 5, 44-52 Wellesley St West, Auckland
 T. +64 (0) 9 309 0101
 F. +64 (0) 9 309 0176
 http://www.aucklandfestival.co.nz
 © Auckland Festival Trust

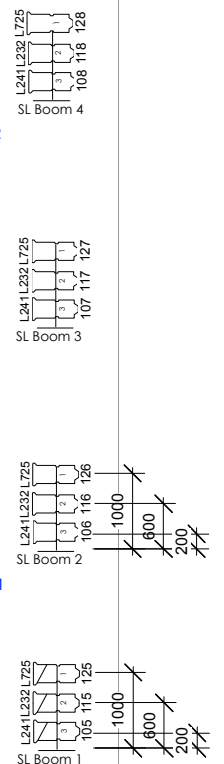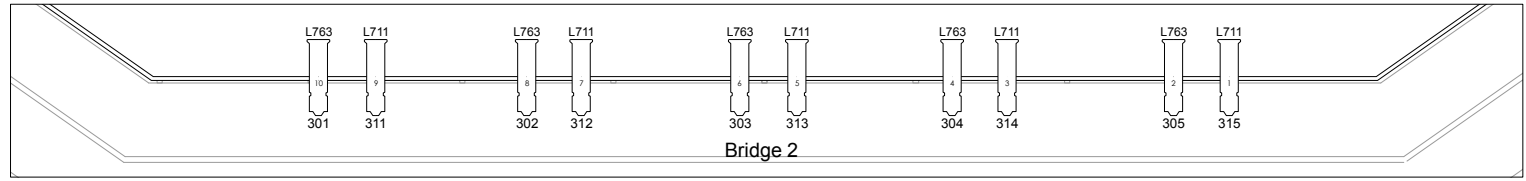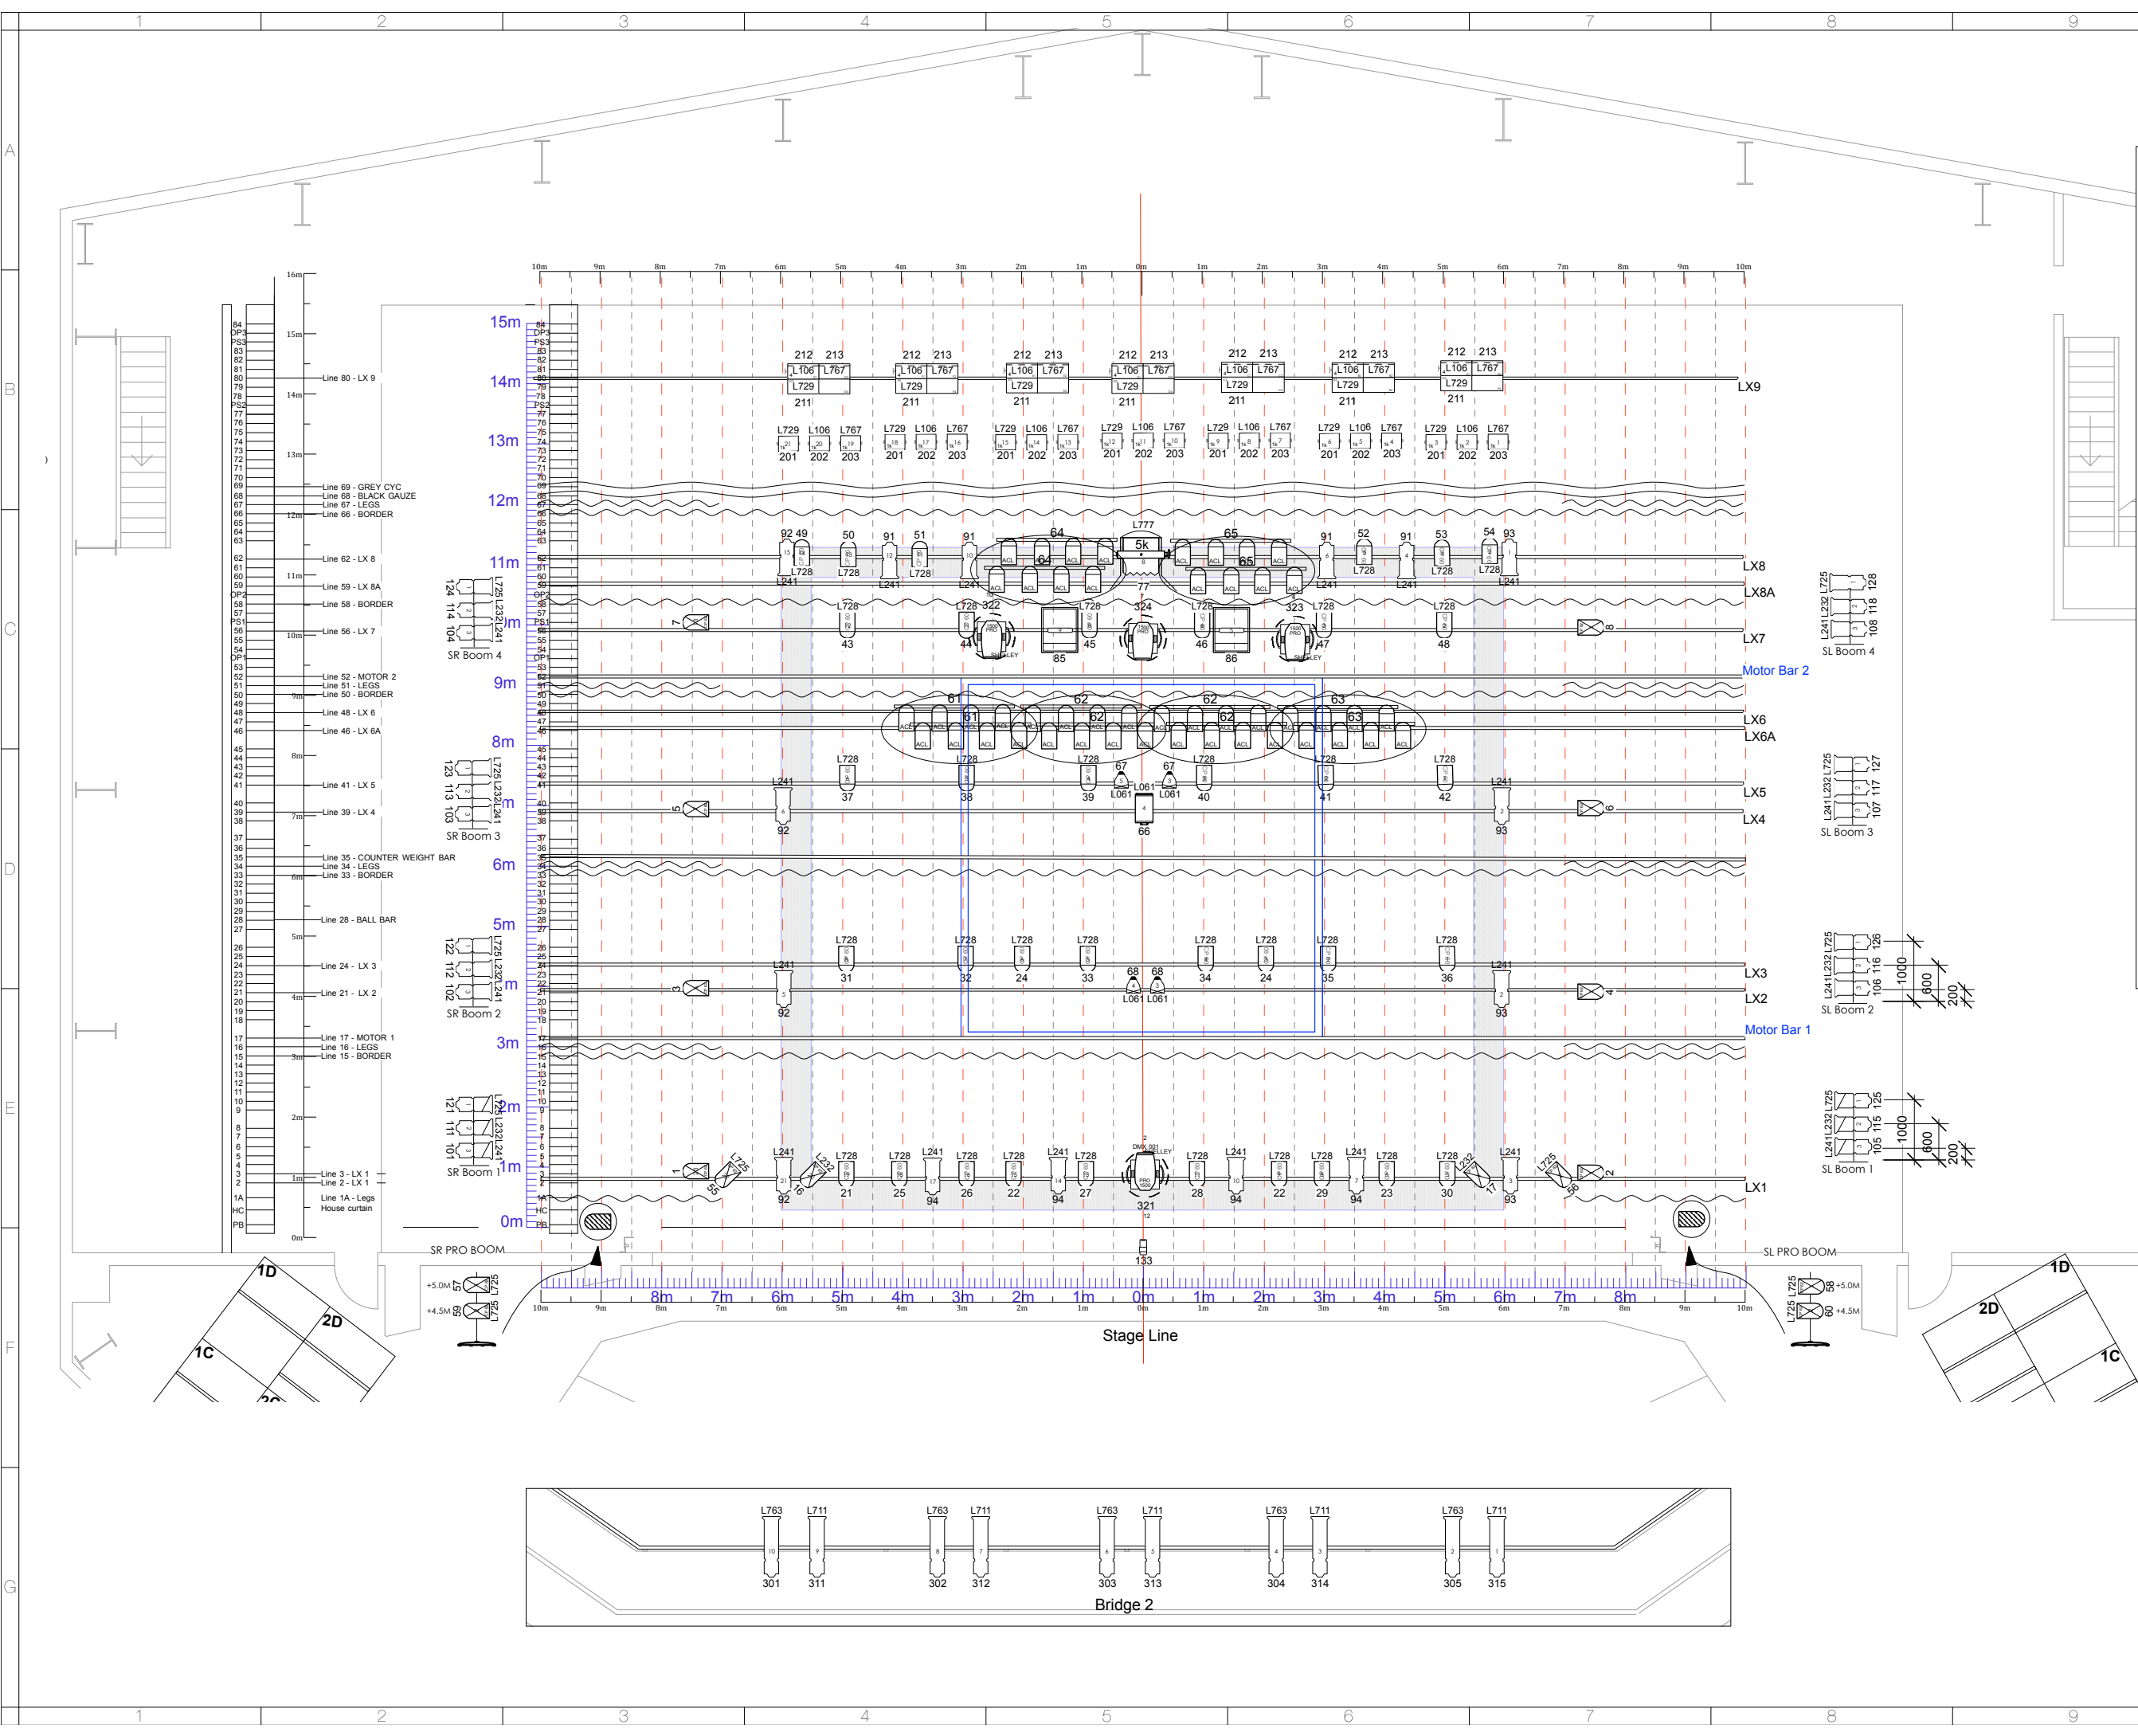

- Line 84 - DPS
- Line 83 - PS
- Line 82 - PS
- Line 81 - PS
- Line 80 - LX 9
- Line 79 - PS
- Line 78 - PS
- Line 77 - PS
- Line 76 - PS
- Line 75 - PS
- Line 74 - PS
- Line 73 - PS
- Line 72 - PS
- Line 71 - PS
- Line 70 - PS
- Line 69 - GREY CYC
- Line 68 - BLACK GAUZE
- Line 67 - LEGS
- Line 66 - BORDER
- Line 65 - PS
- Line 64 - PS
- Line 63 - PS
- Line 62 - LX 8
- Line 61 - PS
- Line 60 - PS
- Line 59 - LX 8A
- Line 58 - BORDER
- Line 57 - PS
- Line 56 - LX 7
- Line 55 - PS
- Line 54 - PS
- Line 53 - PS
- Line 52 - MOTOR 2
- Line 51 - LEGS
- Line 50 - BORDER
- Line 49 - PS
- Line 48 - LX 6
- Line 47 - PS
- Line 46 - LX 6A
- Line 45 - PS
- Line 44 - PS
- Line 43 - PS
- Line 42 - PS
- Line 41 - LX 5
- Line 40 - PS
- Line 39 - LX 4
- Line 38 - PS
- Line 37 - PS
- Line 36 - PS
- Line 35 - COUNTER WEIGHT BAR
- Line 34 - LEGS
- Line 33 - BORDER
- Line 32 - PS
- Line 31 - PS
- Line 30 - PS
- Line 29 - PS
- Line 28 - BALL BAR
- Line 27 - PS
- Line 26 - PS
- Line 25 - PS
- Line 24 - LX 3
- Line 23 - PS
- Line 22 - PS
- Line 21 - LX 2
- Line 20 - PS
- Line 19 - PS
- Line 18 - PS
- Line 17 - MOTOR 1
- Line 16 - LEGS
- Line 15 - BORDER
- Line 14 - PS
- Line 13 - PS
- Line 12 - PS
- Line 11 - PS
- Line 10 - PS
- Line 9 - PS
- Line 8 - PS
- Line 7 - PS
- Line 6 - PS
- Line 5 - PS
- Line 4 - PS
- Line 3 - LX 1
- Line 2 - LX 1
- Line 1A - Legs
- Line 1B - House curtain