



REVISION NOTES

- 1. MECHANICAL EQUIPMENT NUMBERS REVISED

AIR HANDLING UNIT ZONE REFERENCE:


- AHU-PB-G-17**  
AIR HANDLING UNIT FOR GATE AND OFFICES
- AHU-PB-G-15**  
AIR HANDLING UNIT FOR LEVEL 2 DEPARTURE CORRIDOR
- AHU-PB-G-16**  
AIR HANDLING UNIT FOR LEVEL 2 BOARDING AREA
- AHU-PB-G-15**  
AIR HANDLING UNIT FOR LEVEL 1 ARRIVAL CORRIDOR

EQUIPMENT REFERENCE

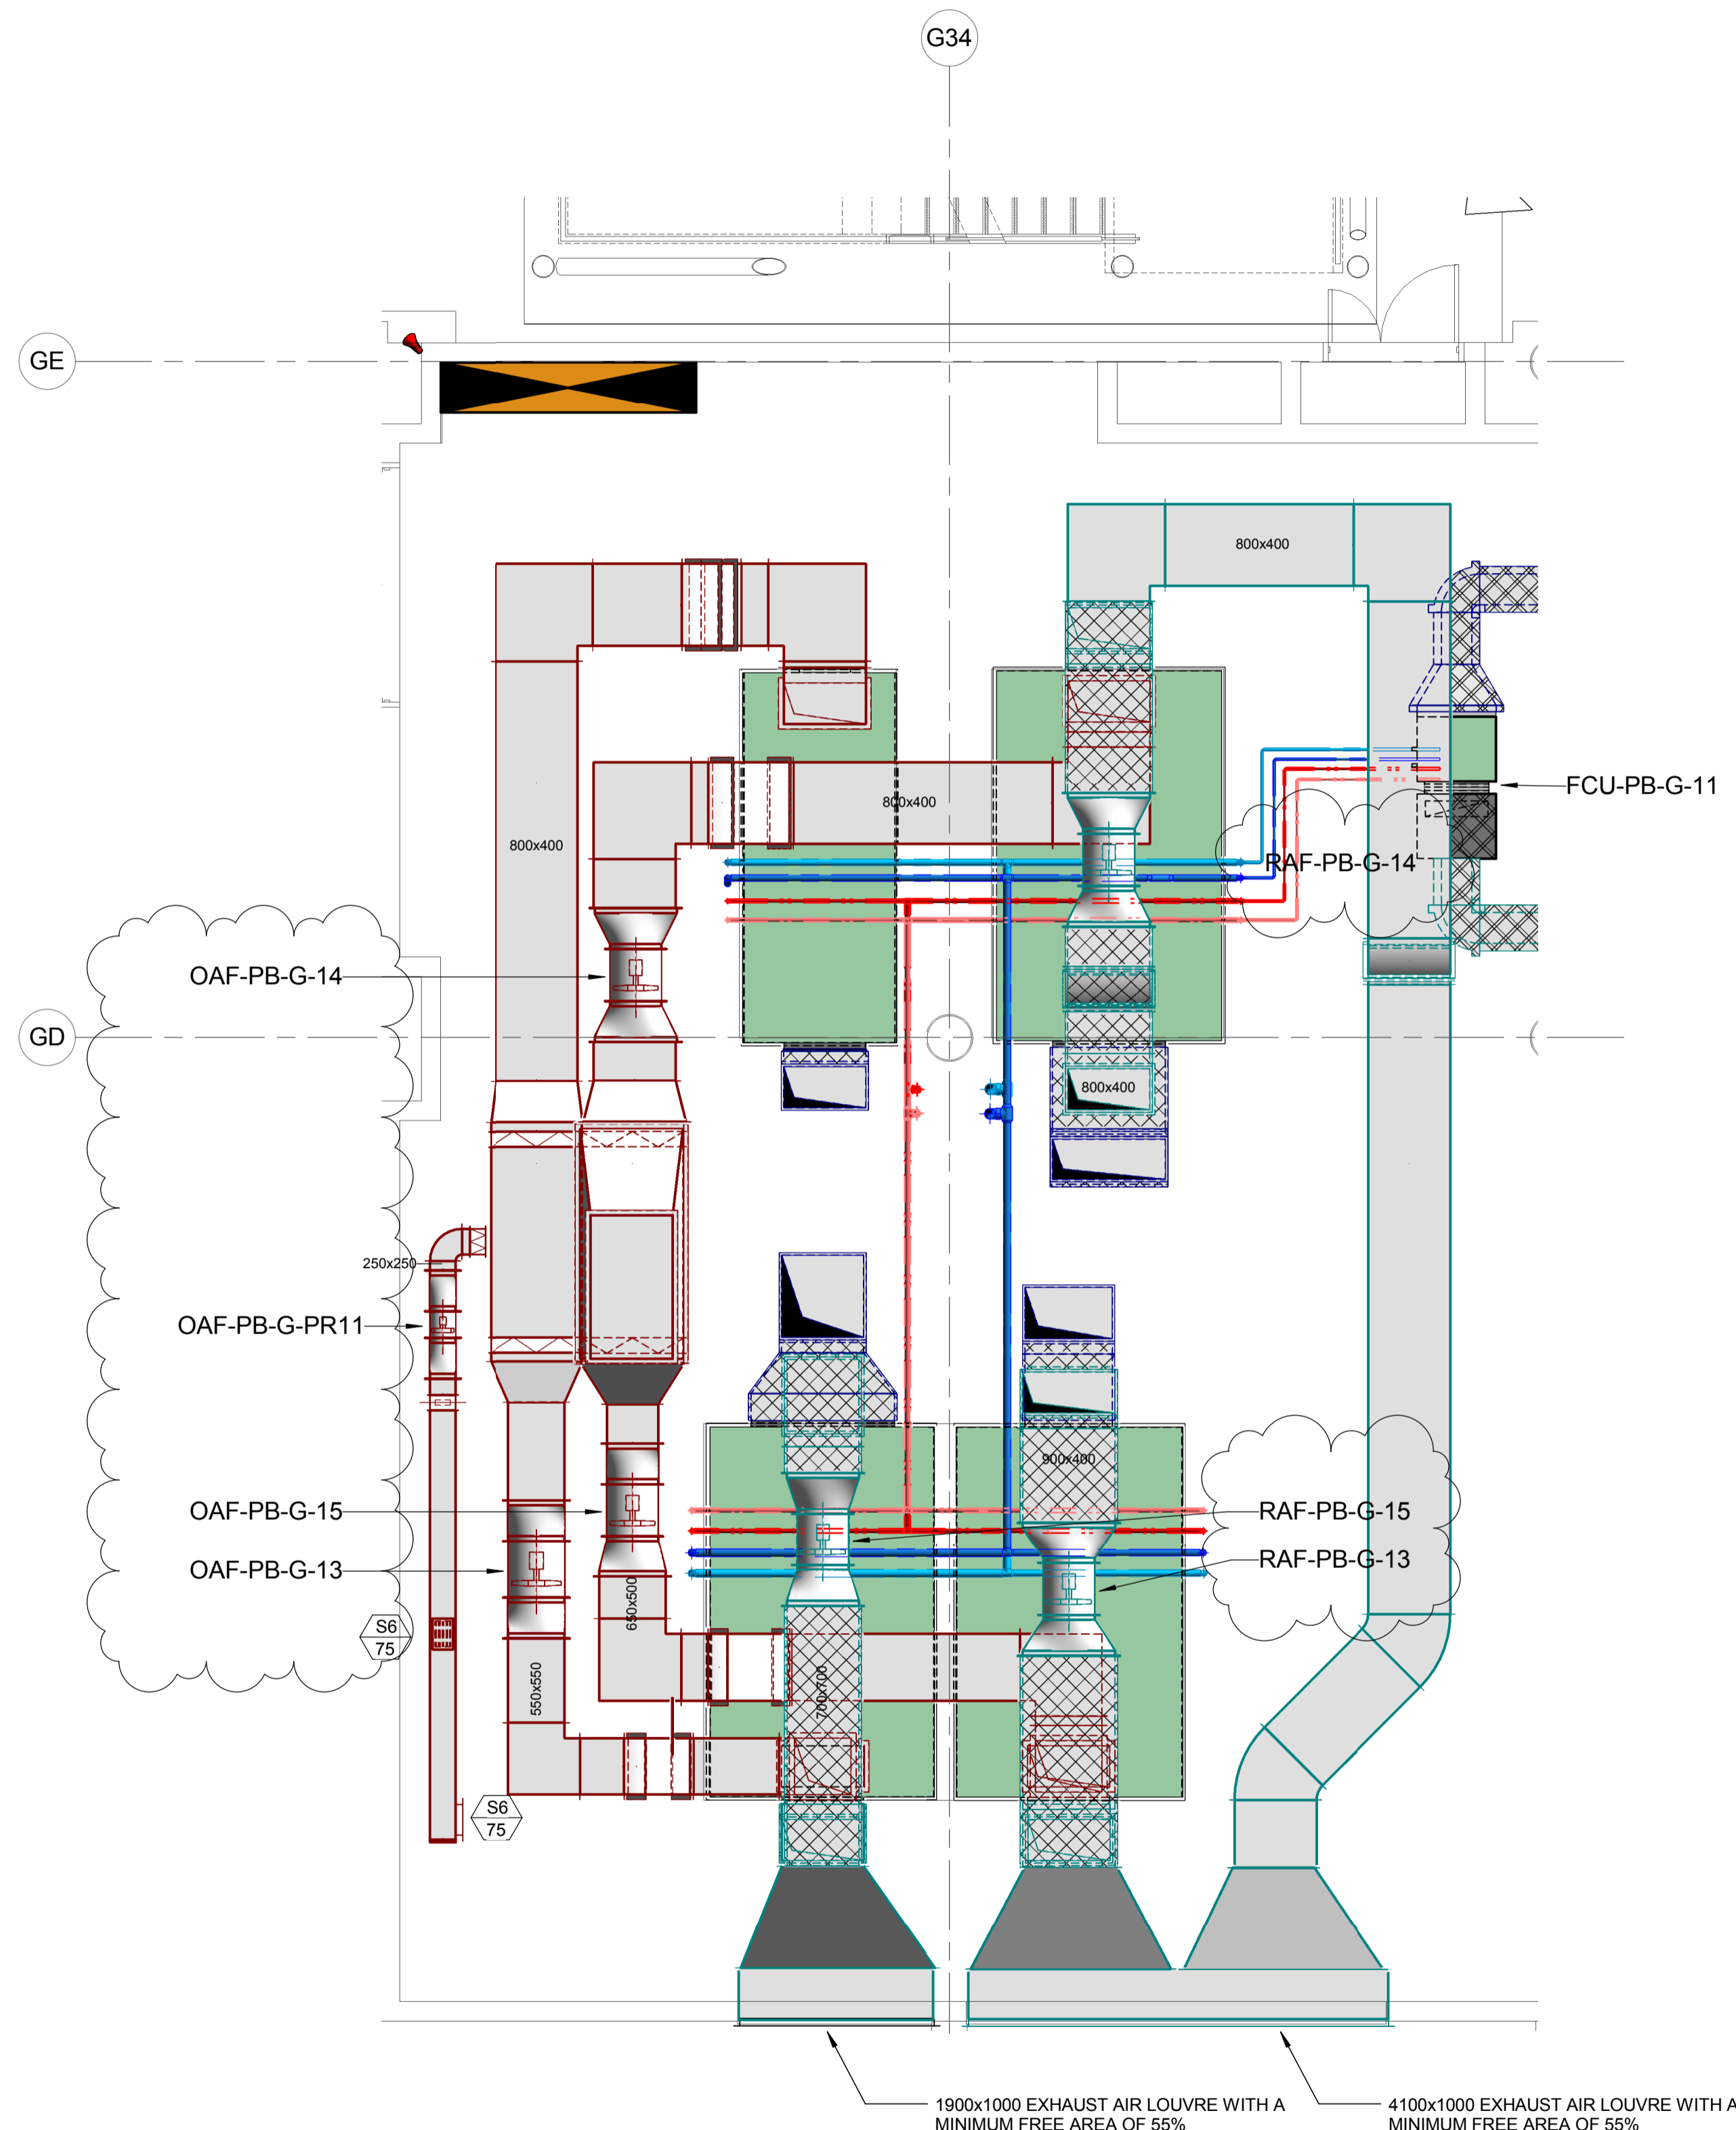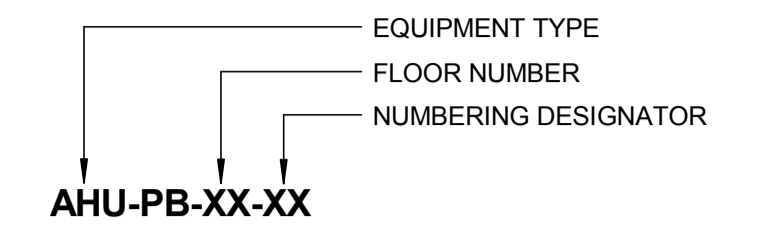

GATE 18 MECHANICAL PLANT

SCALE: 1 : 50

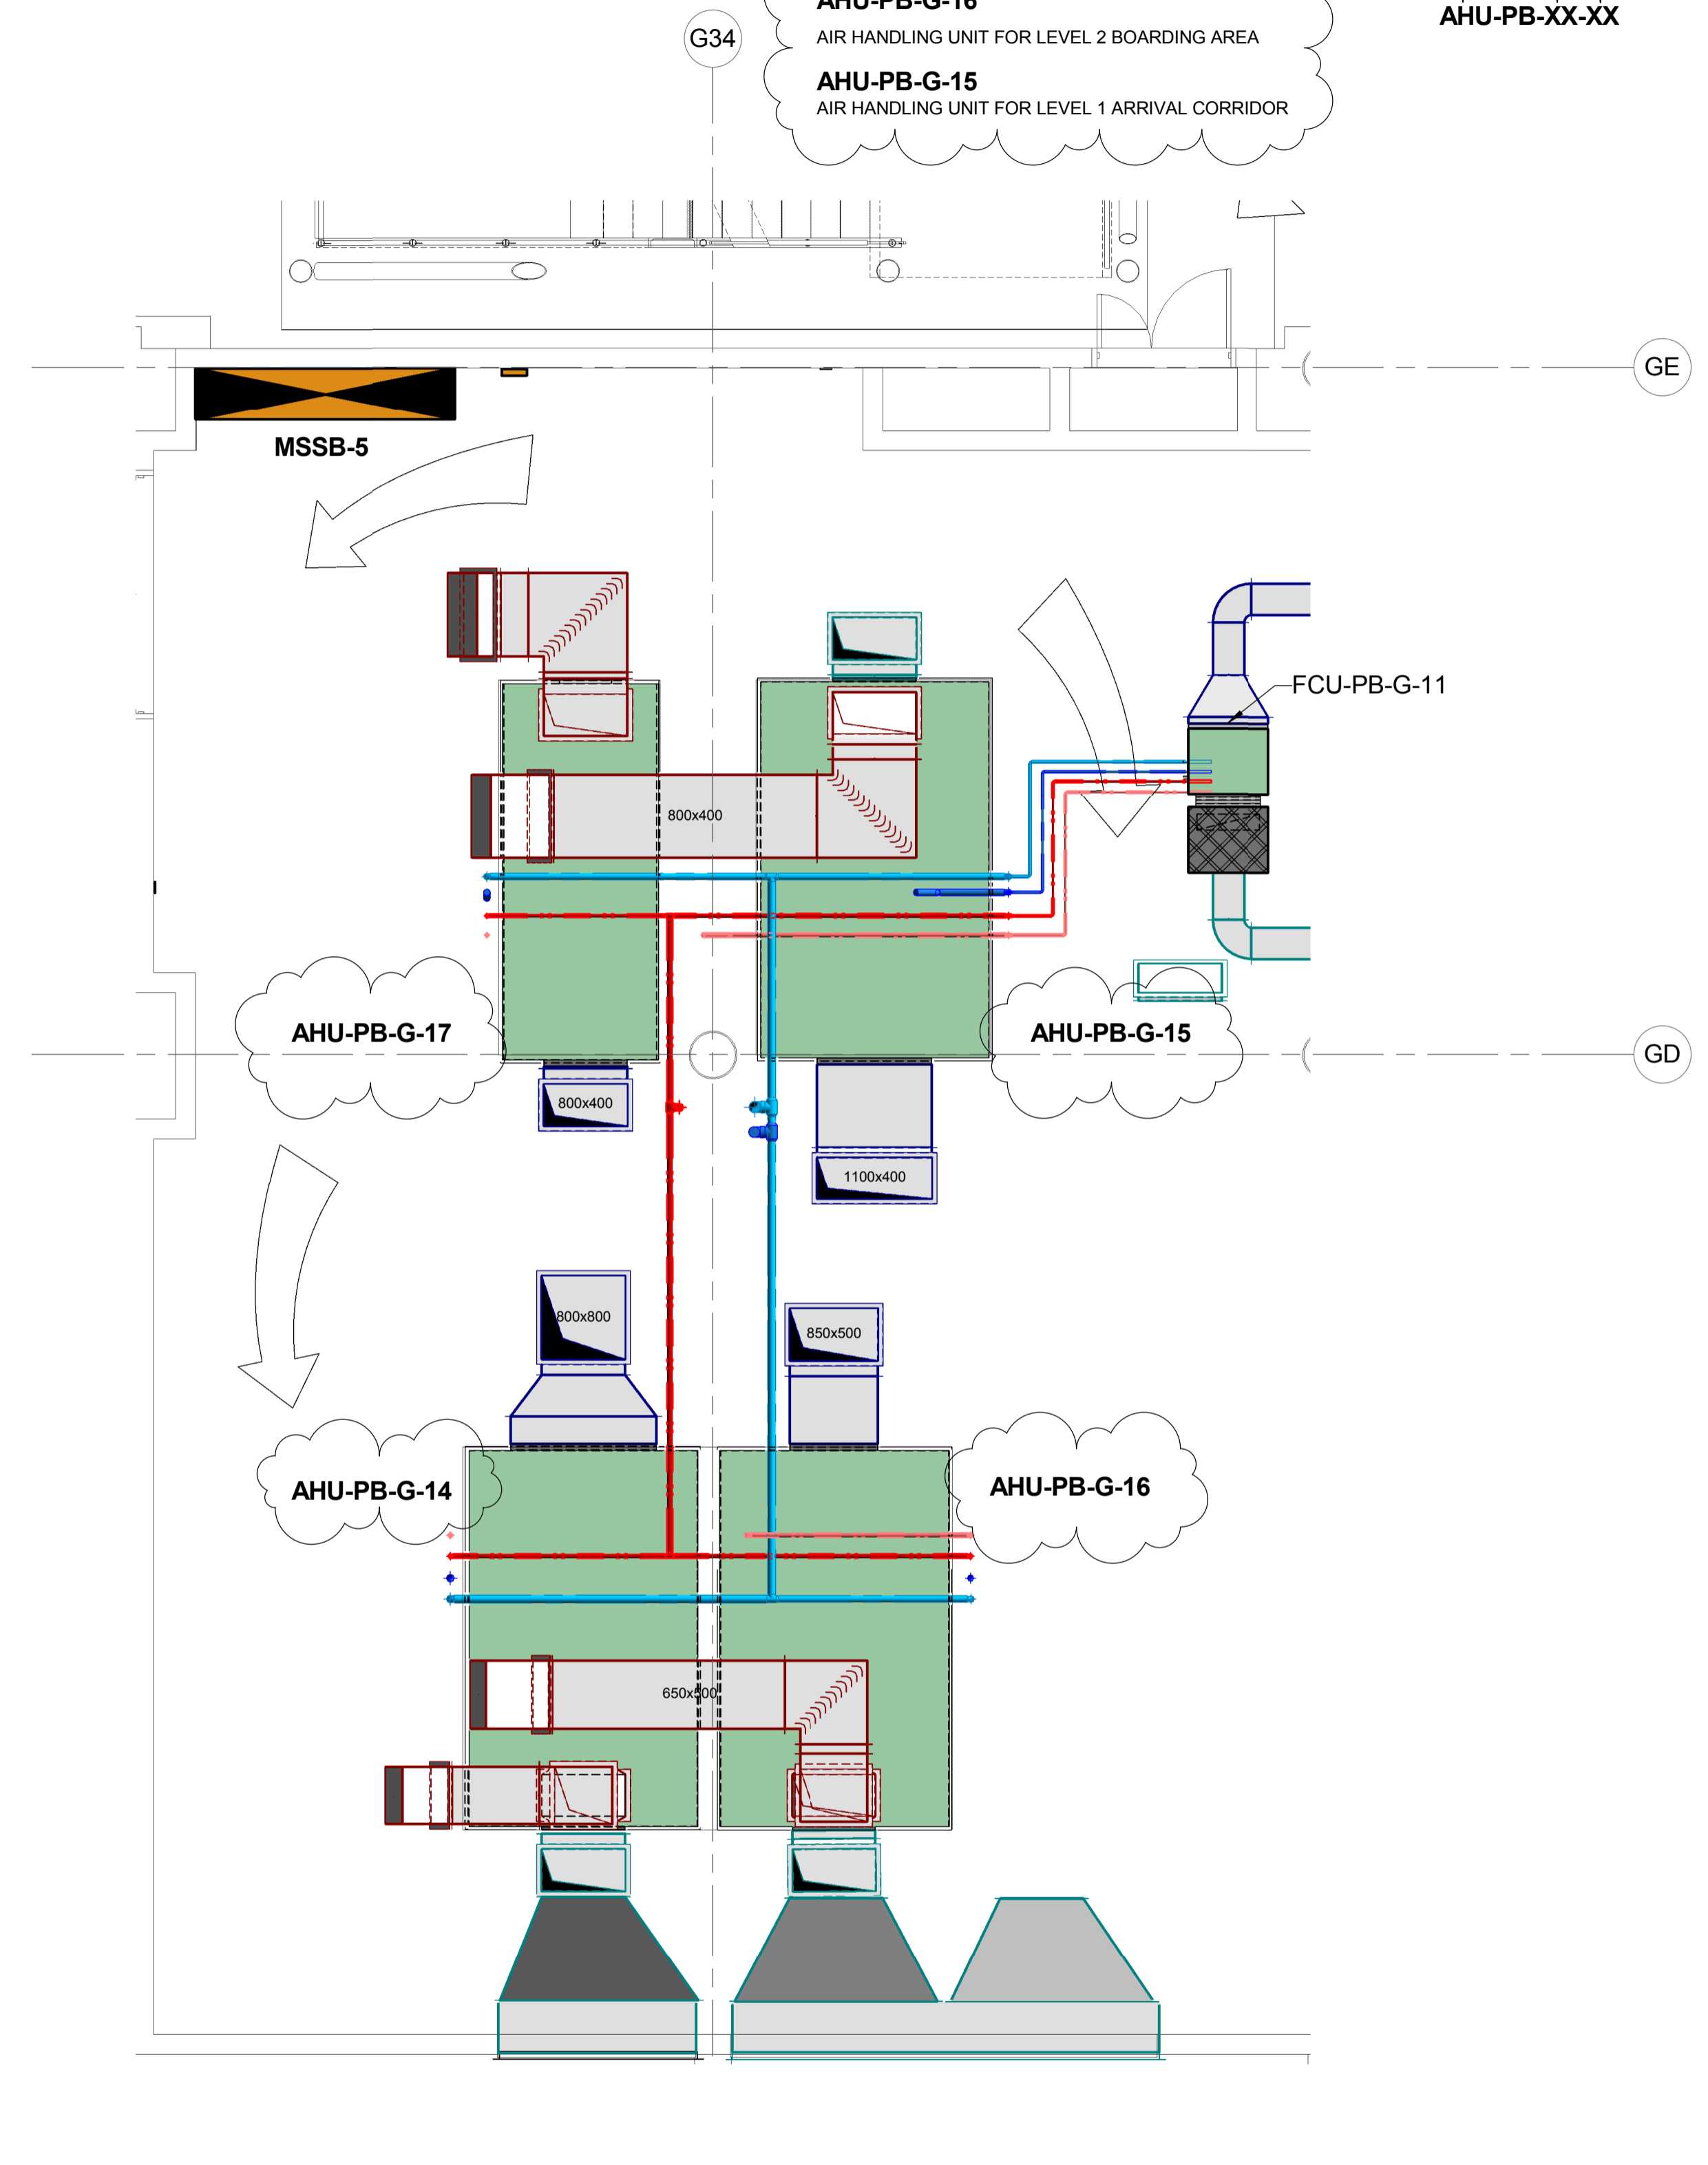

GATE 18 MECHANICAL PLANT - LOW LEVEL

SCALE: 1 : 50

FOR CONSTRUCTION




CONSULTANT  
 AECOM New Zealand Limited  
 AECOM House, 8 Mahuhu Crescent  
 Auckland 1010, Auckland, NZ 1010  
 +64 9 967 9200 tel +64 9 967 9201 fax  
 www.aecom.com



CONSULTANT  
 Ground Floor, Mason Bros  
 139 Pakenham Street West  
 Wynyard Quarter  
 Auckland 1010  
 New Zealand  
 Phone + 64 9 309 4894

PROJECT  
 AUCKLAND  
 AIRPORT - PIER B

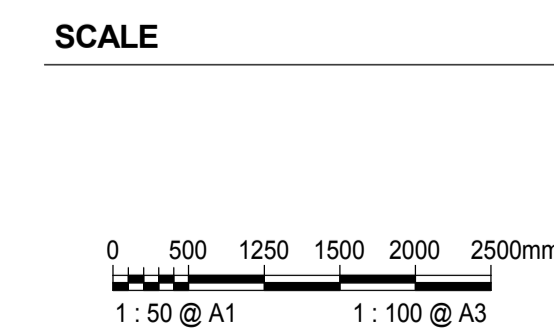

PROJECT MANAGEMENT INITIALS		
MC	NF	SA
DESIGNER	CHECKED	APPROVED

ISSUE/REVISION		
I/R	DATE	DESCRIPTION
01	16/02/2017	FOR CONSTRUCTION
0	23/12/2016	FOR CONSTRUCTION

PROJECT NUMBER  
91345

SHEET TITLE  
MECHANICAL SERVICES  
NEW PLANT GATE 18

SHEET NUMBER  
91345-ACM-DRG-ME-3104